



7251/08/409
MWC DRAWING NUMBER
REV

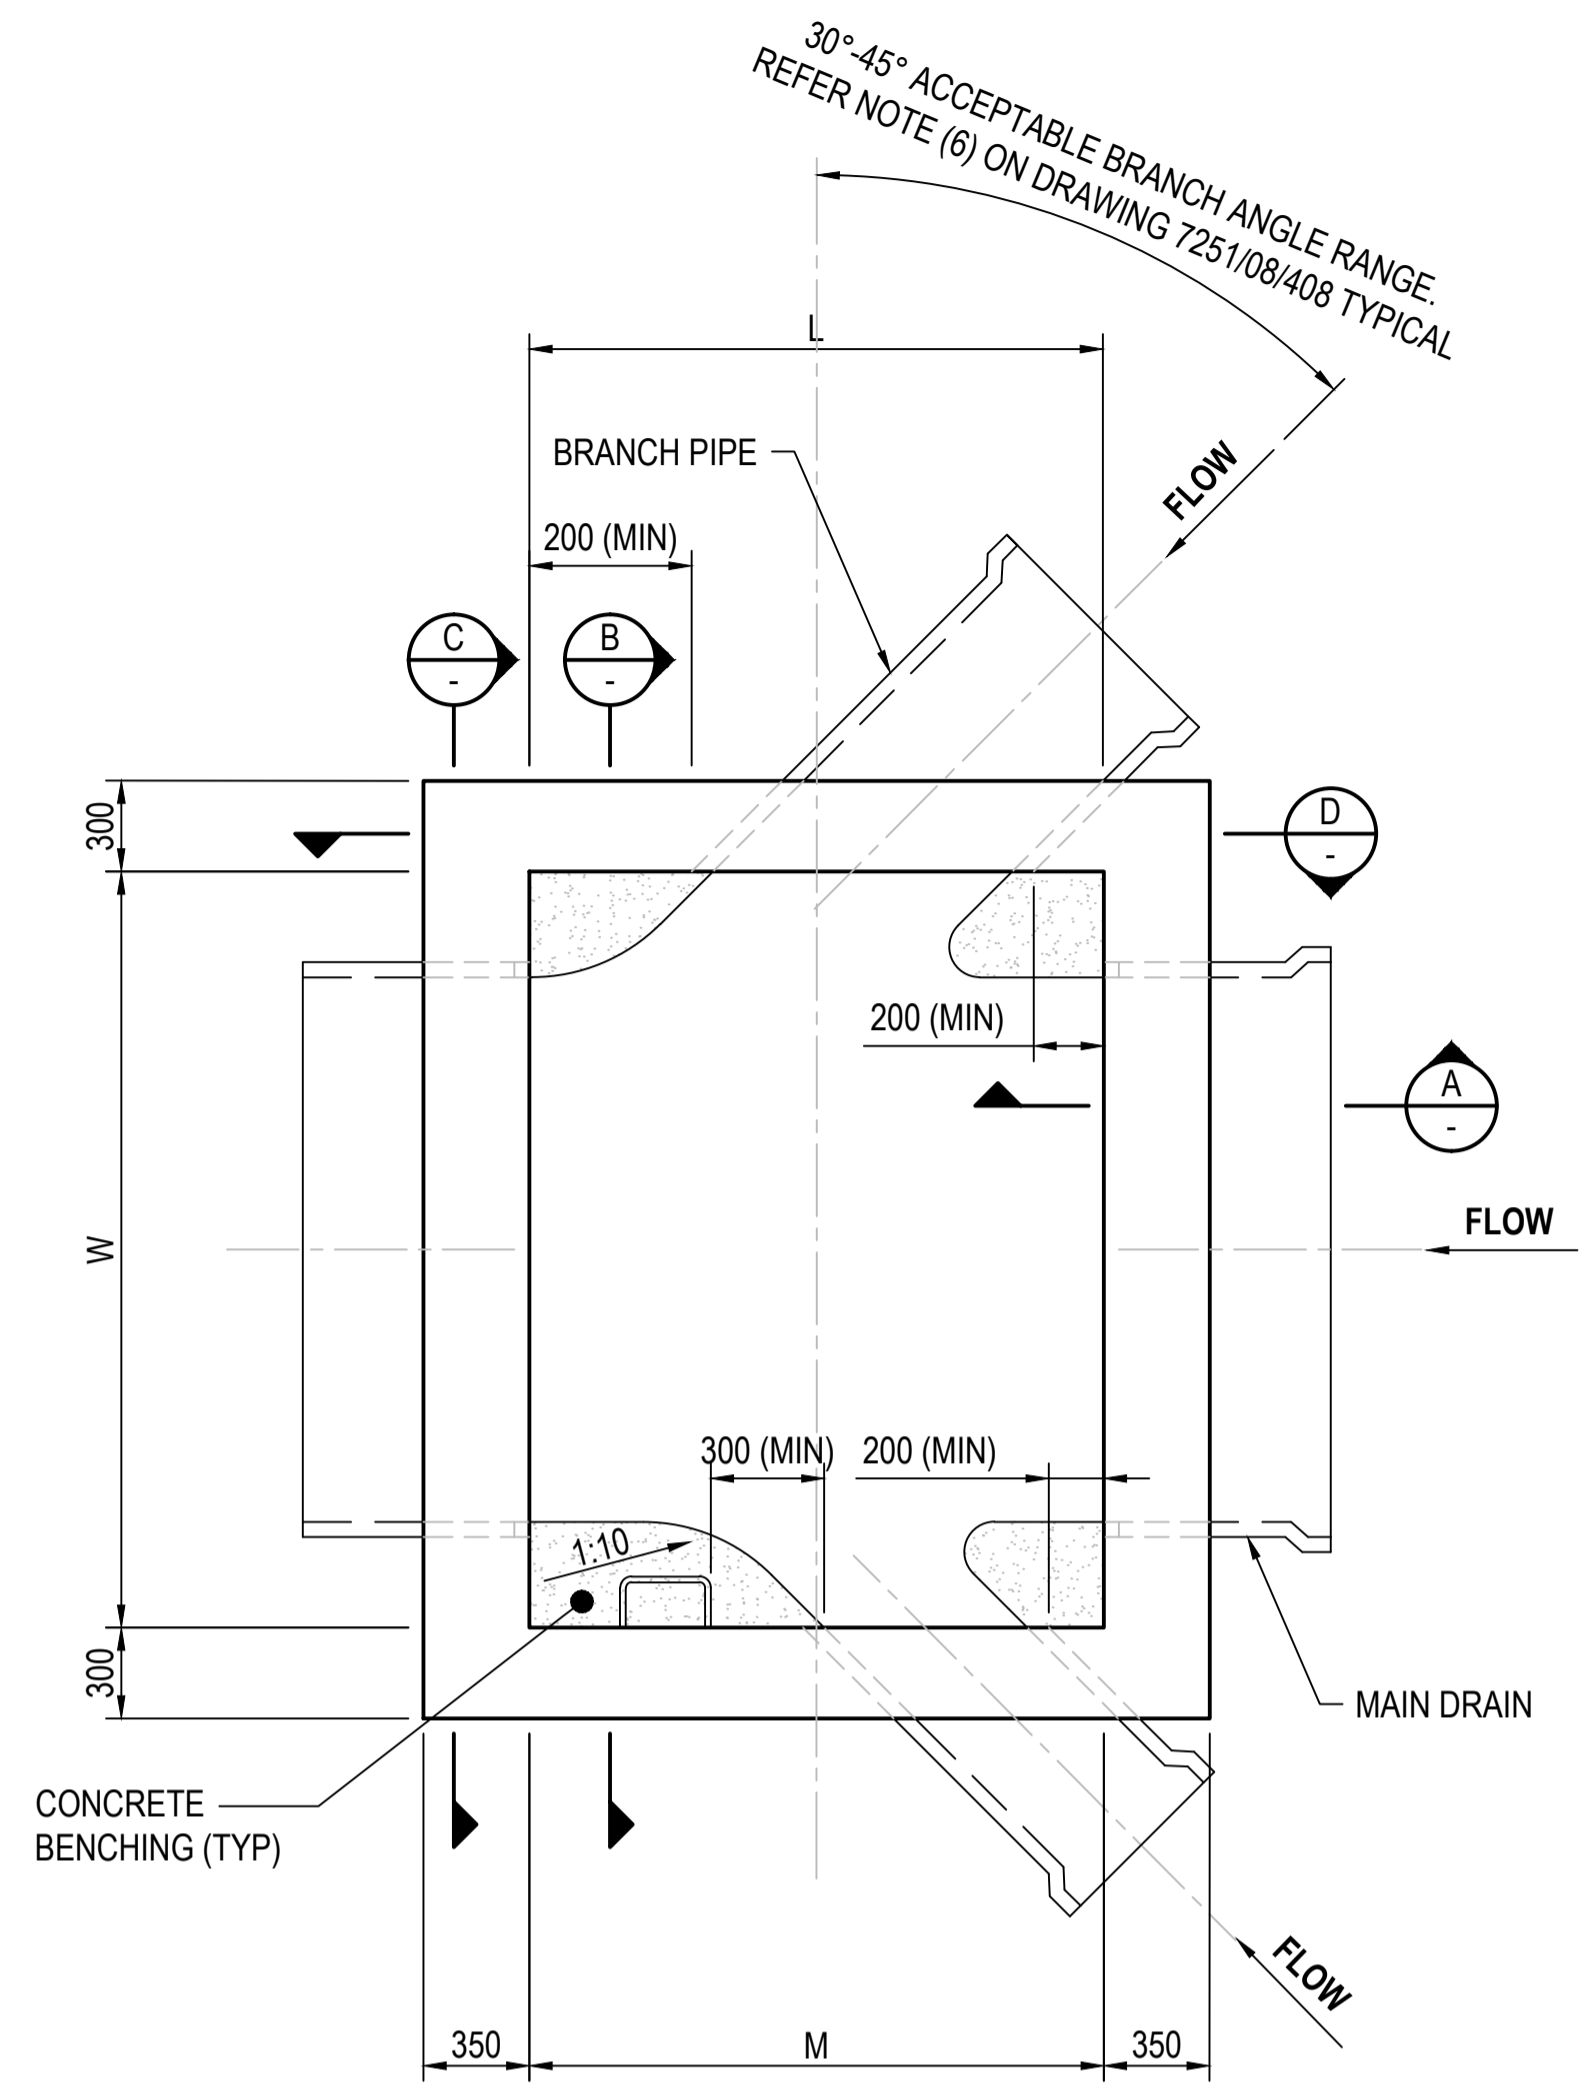


KEY PLAN AT PIT LEVEL

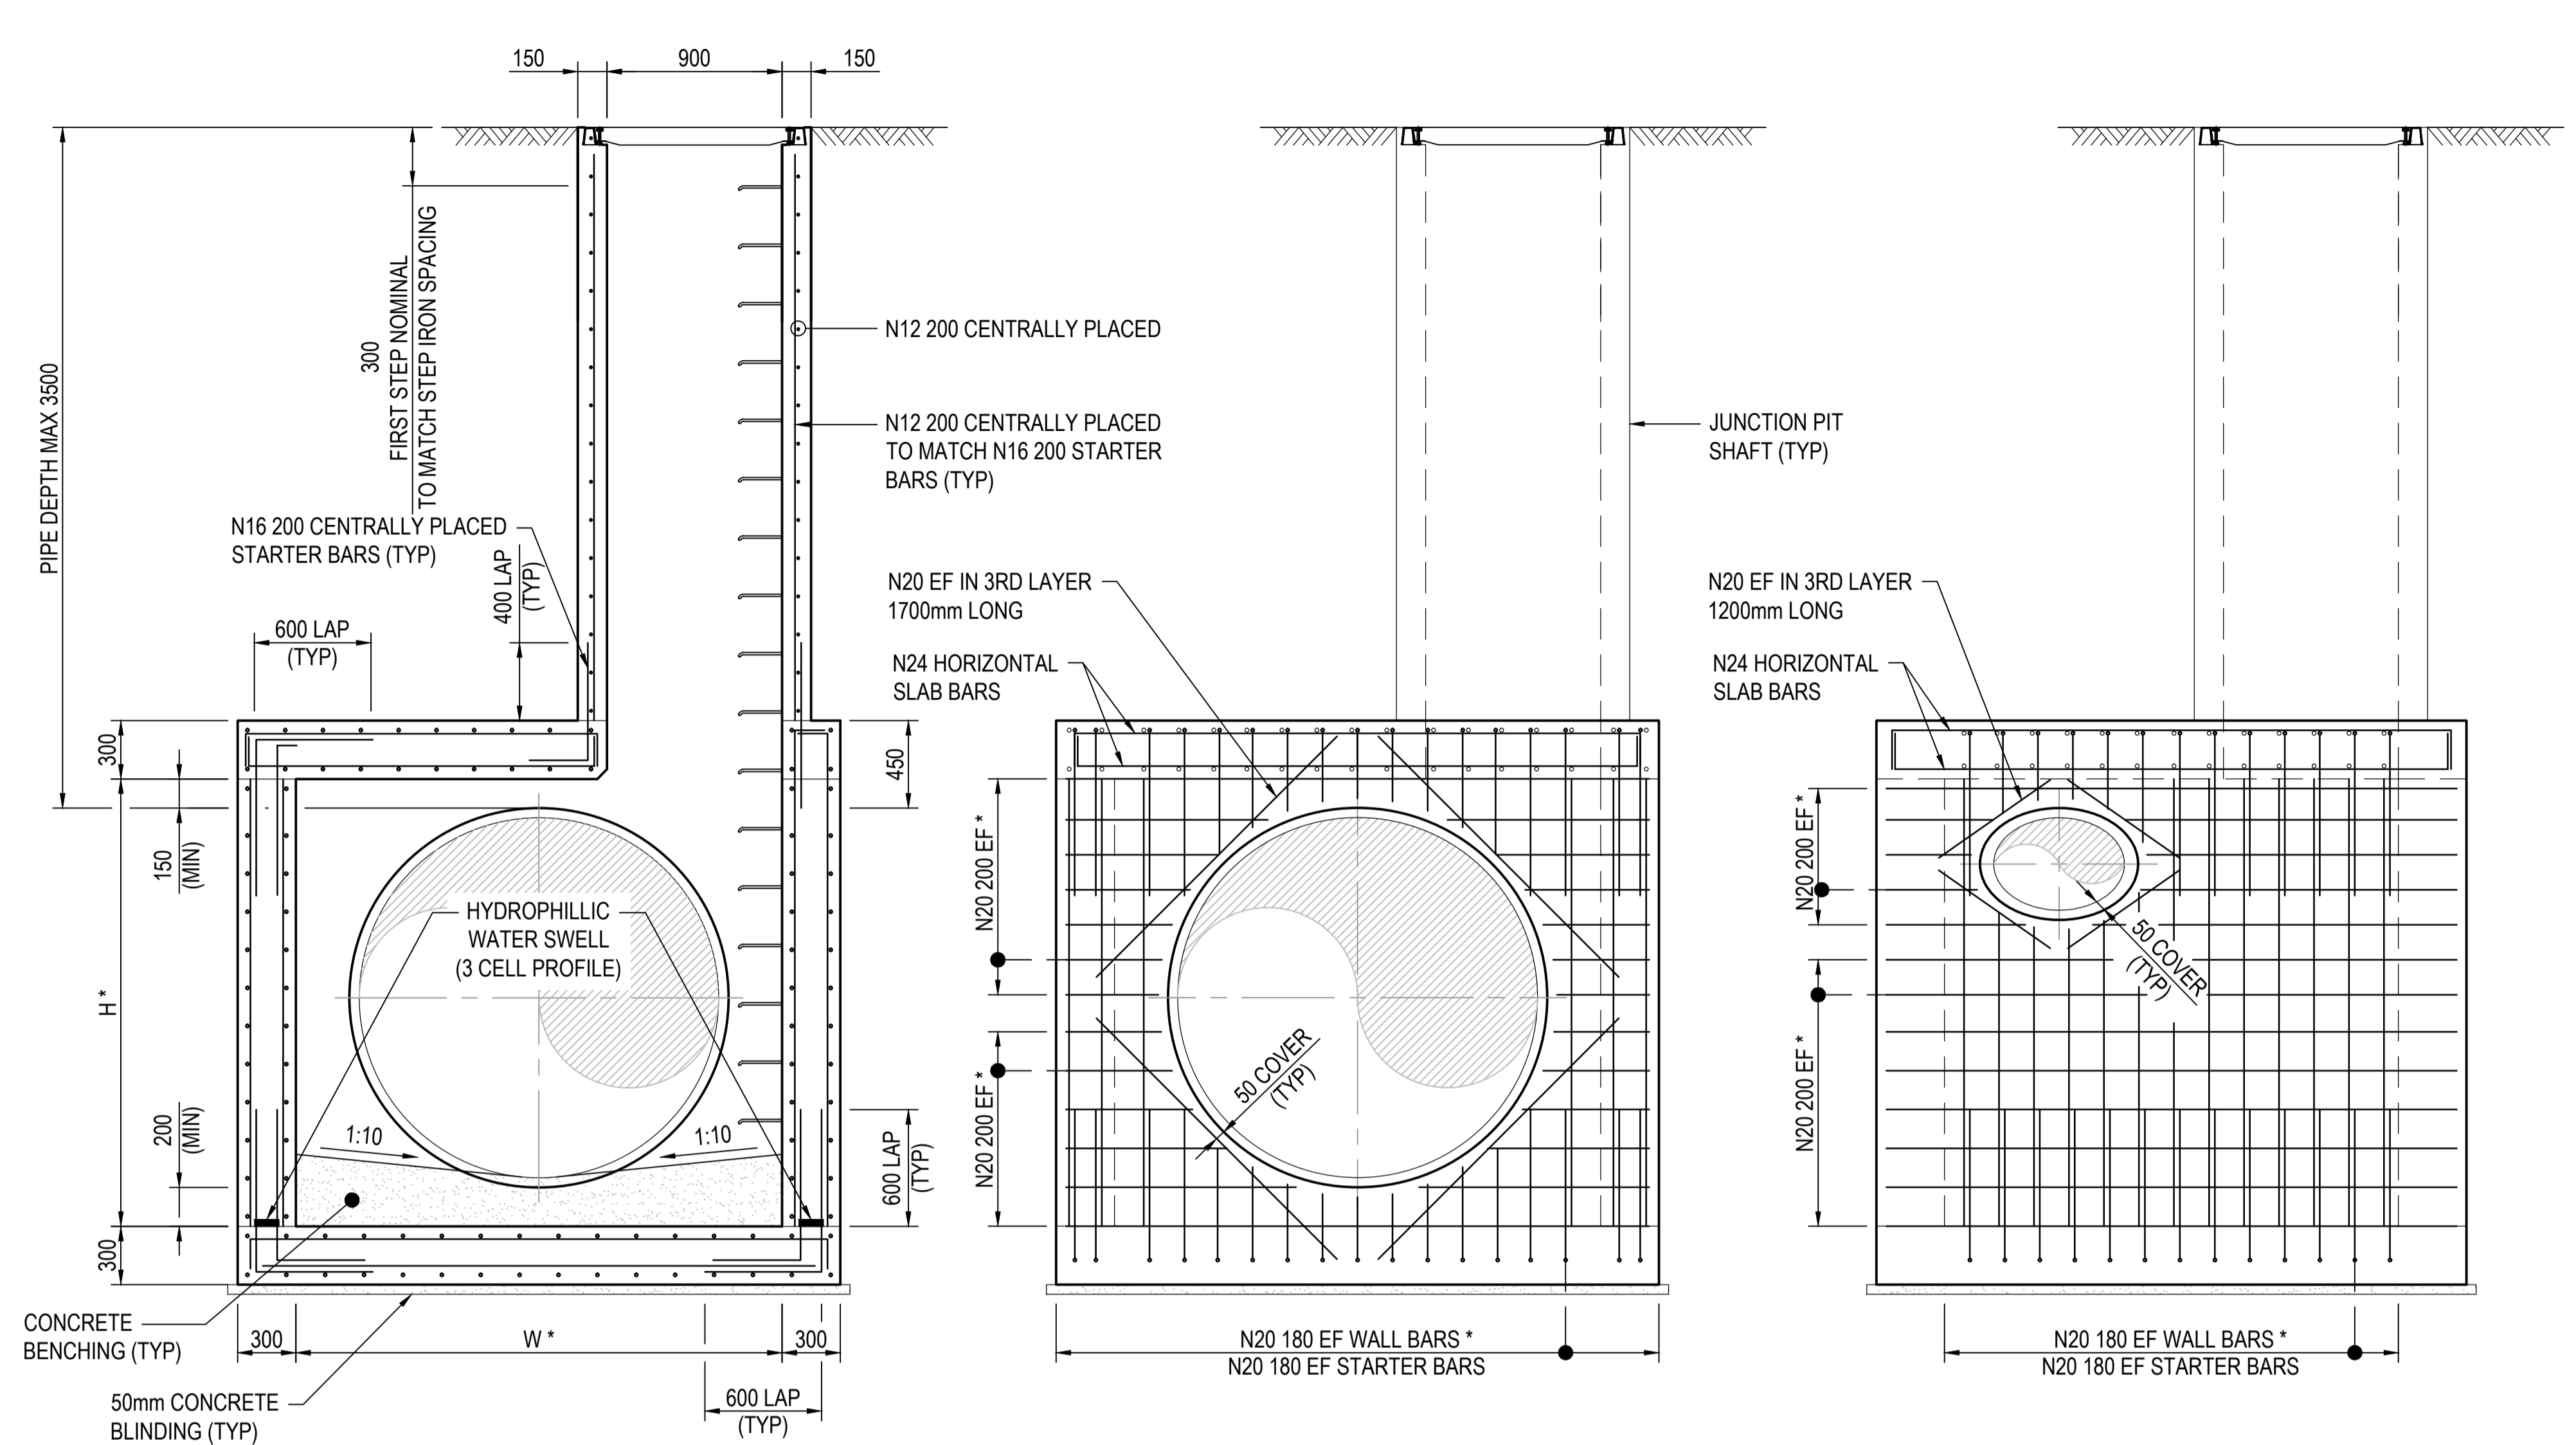

* REFER TABLE ON DRG 7251/08/408


* CUT OFF BARS 50mm CLEAR OF PIPE

* CUT OFF BARS 50mm CLEAR OF PIPE

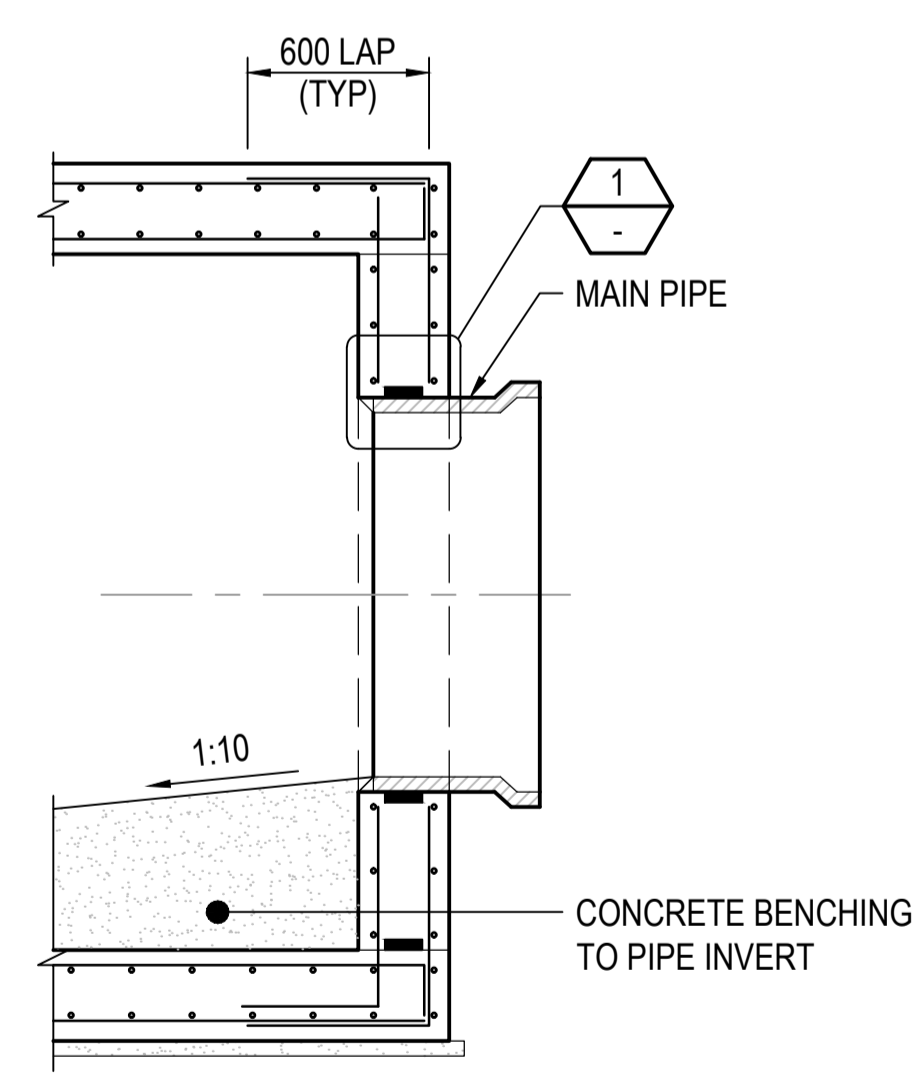


SECTION A
408 / -

SECTION B
408 / -

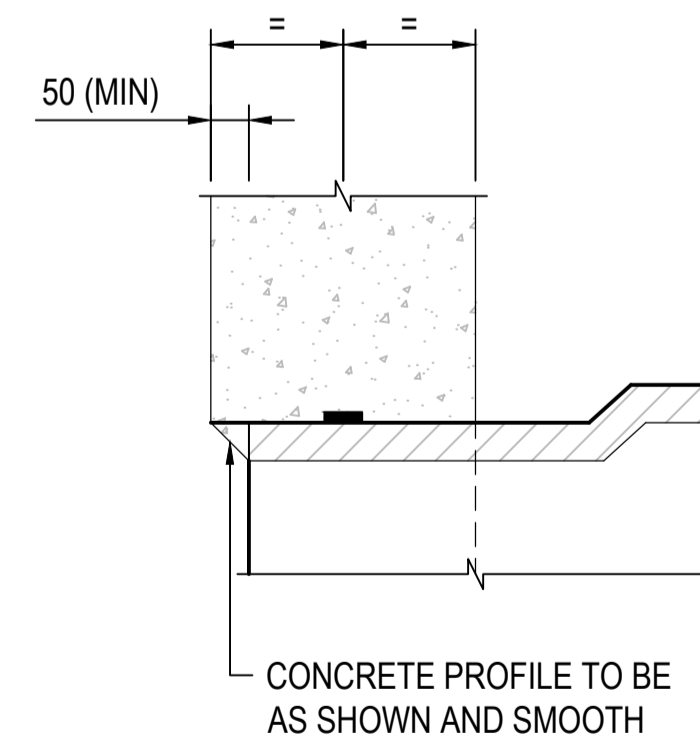


DETAIL 1

SECTION C
408 / - (BASE REINFORCEMENT NOT SHOWN FOR CLARITY)

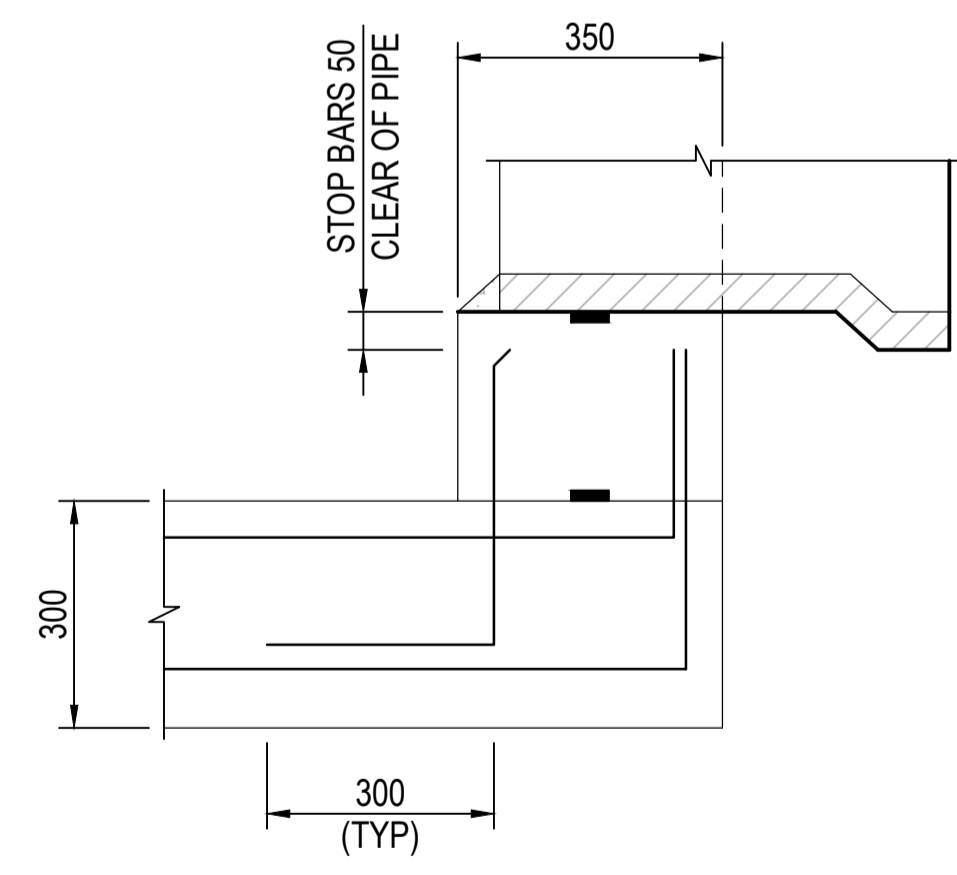

CORNER DETAILS
PLAN VIEW

SECTION D
408 / - (BASE REINFORCEMENT NOT SHOWN FOR CLARITY)

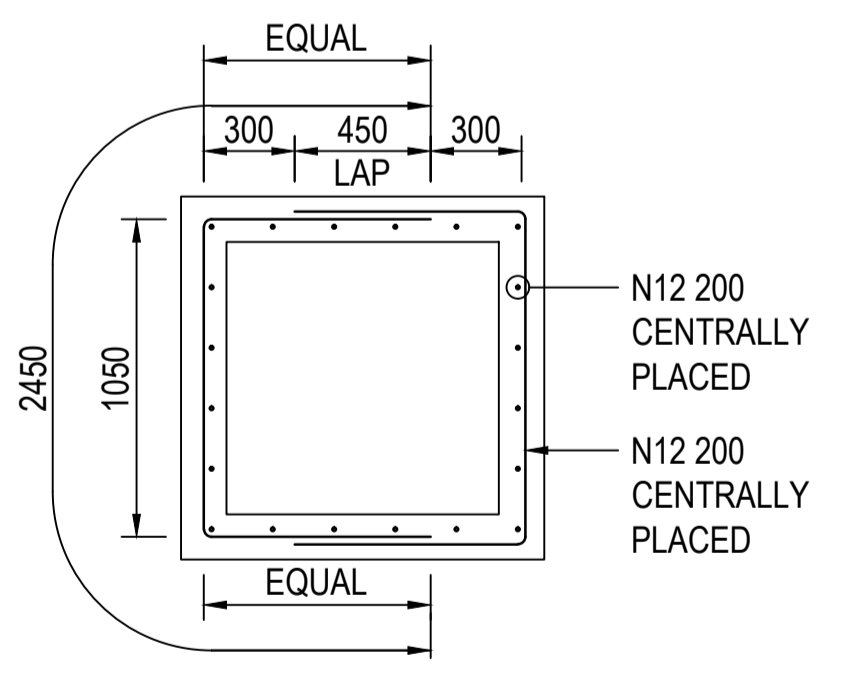

SHAFT REINFORCEMENT DETAIL

* REFER DRAWING 7251/08/408 FOR CONCRETE OUTLINE AND NOTES.

REV	DESCRIPTION	COMPANY	PROJECT OR WO NUMBER	DRAWN	ENG. CHECK	PR. MAN. APP'D	DATE
A	FIRST REVISION			RD	VY	RM	25.11.15

--	--	--	--	--	--	--	--

COPYRIGHT
Copyright - This document is the property of Melbourne Water. Use or copying of the document in whole or in part, for other than Melbourne Water purposes, without the written permission of Melbourne Water constitutes an infringement of copyright.

Melbourne Water DRAINAGE STANDARD DRAWINGS			
DRAFTER RD	DESIGNER GT	DESIGN MANAGER APPROVAL RM	PROJECT MANAGER APPROVAL VY
DRAFTING CHECK BS	ENGINEERING REVIEW VY		

TITLE JUNCTION PITS (≤3.5m DEEP) - SHEET 2 OF 2 FOR PIPELINES UP TO 1800mm DIAMETER			
PROJECT DATUM	Original Size A1	MELBOURNE WATER CORPORATION	
SCALE NTS		7251/08/409	A
		MWC DRAWING NUMBER	REV